




SHEET INDEX:
KB.GN COVER SHEET AND GENERAL NOTES
KB.100 FLOOR PLAN KITCHEN
KB.101 FLOOR PLAN BATHROOM
KB.200 CONSTRUCTION PLAN
KB.300 MECHANICAL PLAN
KB.400 REFLECTED CEILING PLANS (RCP)
KB.500 COUNTER TOP PLAN
KB.600 ELEVATION
KB.601 ELEVATION
KB.602 ELEVATION
KB.603 ELEVATION
KB.604 ELEVATION
KB.605 ELEVATION

ALL DIMENSIONS AND SIZE DESIGNATIONS GIVEN ARE SUBJECT TO VERIFICATION ON JOB SITE AND ADJUSTMENT TO FIT JOB CONDITIONS.		DESIGN PLANS ARE PROVIDED FOR THE FAIR USE BY THE CLIENT OR HIS AGENT IN COMPLETING THE PROJECT AS LISTED WITHIN THIS CONTRACT. DESIGN PLANS REMAIN THE PROPERTY OF THIS FIRM AND CAN NOT BE USED OR REUSED WITHOUT PERMISSION.	DESIGNED FOR: LYDIA BACHMAN	BY: ISABELLE BOUDREAU		DATE	BY	SCALE	DWG NO.
								$\frac{1}{2}" = 1'-0"$	KB.GN
					PWN				
					RV				

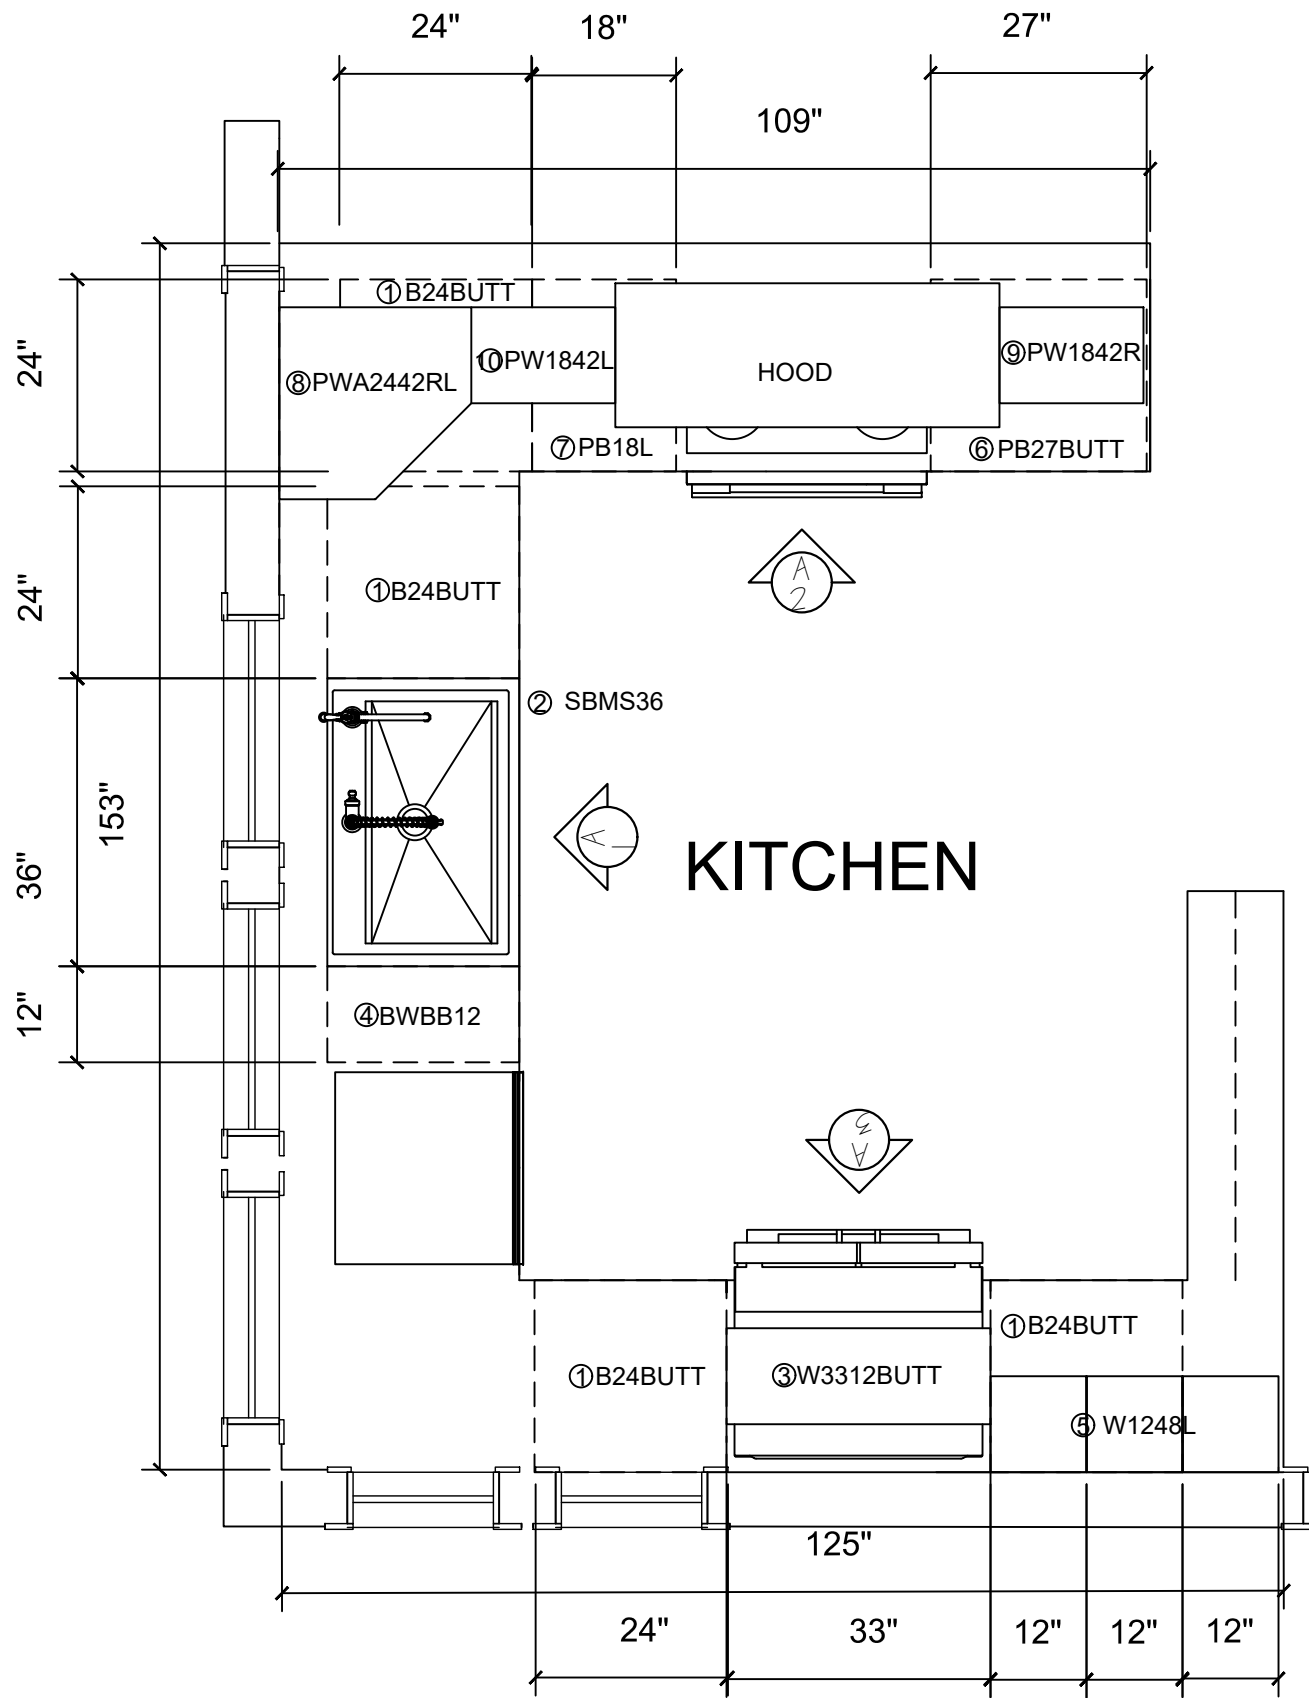

Ⓢ

- FLOOR PLAN SPECIFICATIONS:
CABINETS
APPLIANCES
FIXTURES
ALIGN EACH WITH REFERENCE
- ① BASE CABINET B24BUTT
 - ② SINK SBMS36
 - ③ REFRIGERATOR W3312BUTT
 - ④ TRASH CAN CABINET BWBB12
 - ⑤ LONG WALL CABINETS W1248L
 - ⑥ PENINSULA CABINET 1 PB27BUTT
 - ⑦ PENINSULA CABINET 2 PB18L
 - ⑧ PENINSULA CORNER CABINET PWA2442RL
 - ⑨ PENINSULA WALL CABINET 1 PW1842R
 - ⑩ PENINSULA WALL CABINET 1 PW1842L

LEGEND AND SYMBOLS

 ELEVATION TAG

DESIGN PLANS ARE PROVIDED FOR THE FAIR USE BY THE CLIENT OR HIS AGENT IN COMPLETING THE PROJECT AS LISTED WITHIN THIS CONTRACT. DESIGN PLANS REMAIN THE PROPERTY OF THIS FIRM AND CAN NOT BE USED OR REUSED WITHOUT PERMISSION.

ALL DIMENSIONS AND SIZE DESIGNATIONS GIVEN ARE SUBJECT TO VERIFICATION ON JOB SITE AND ADJUSTMENT TO FIT JOB CONDITIONS.

DESIGNED FOR: **LYDIA BACHMAN**

BY: **ISABELLE BOUDREAU**

DATE

BY

SCALE

DWG NO.


KB.100

1" = 1'-0"


B

BATHROOM FLOOR PLAN

1/2" = 1'-0"

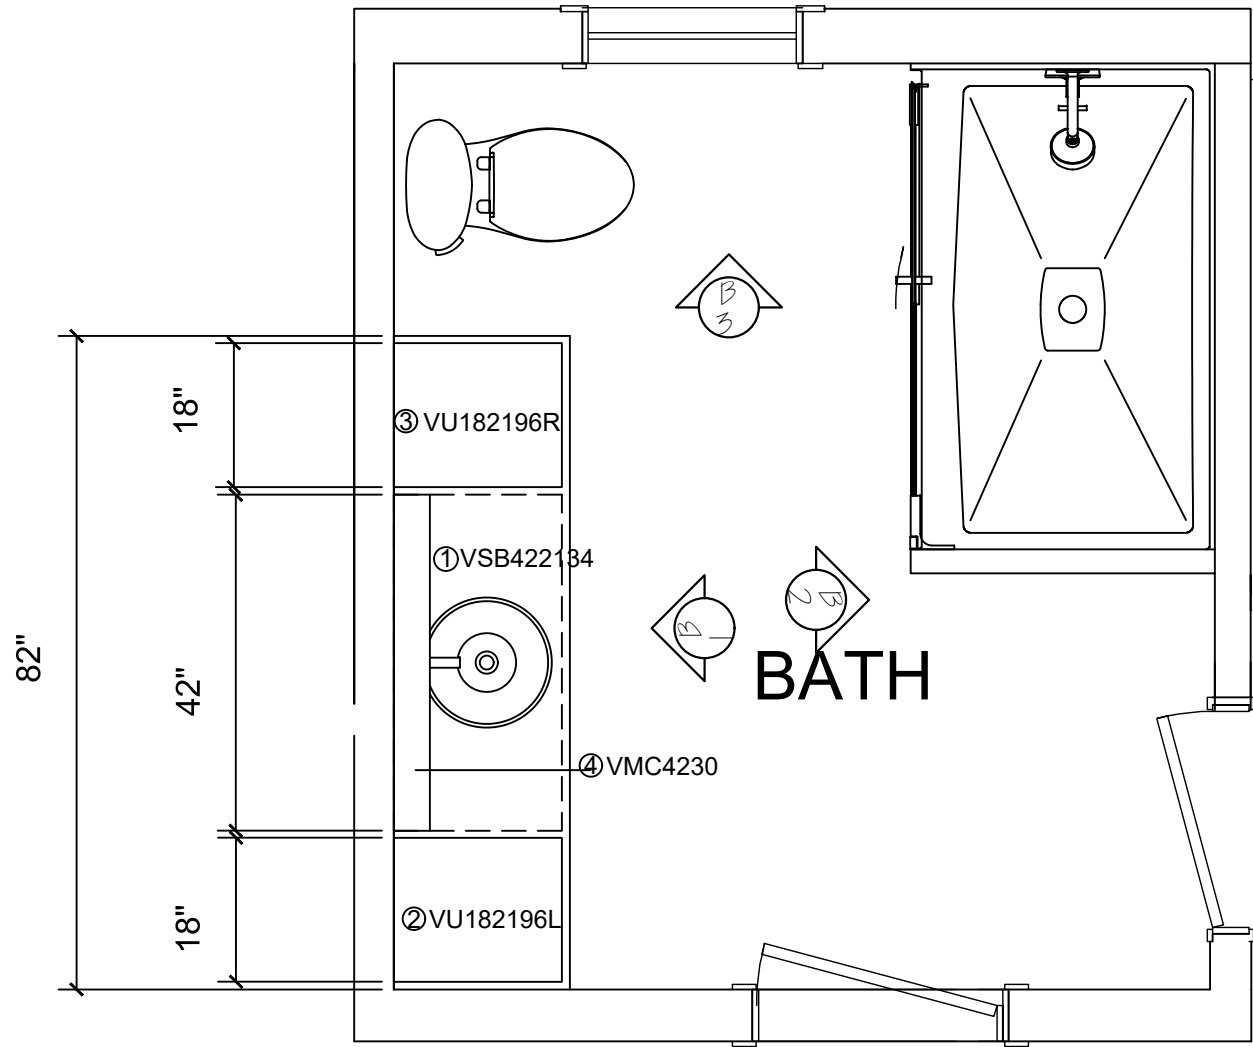

- FLOOR PLAN SPECIFICATIONS:
CABINETS
APPLIANCES
FIXTURES
ALIGN EACH WITH REFERENCE
- ① SINK VSB422134
 - ② TALL WALL CABINET VU182196L
 - ③ TALL WALL CABINET VU182196R
 - ④ VANITY MIRROR VMC4230

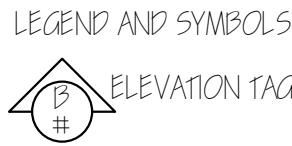

ALL DIMENSIONS AND SIZE DESIGNATIONS GIVEN ARE SUBJECT TO VERIFICATION ON JOB SITE AND ADJUSTMENT TO FIT JOB CONDITIONS.

DESIGN PLANS ARE PROVIDED FOR THE FAIR USE BY THE CLIENT OR HIS AGENT IN COMPLETING THE PROJECT AS LISTED WITHIN THIS CONTRACT. DESIGN PLANS REMAIN THE PROPERTY OF THIS FIRM AND CAN NOT BE USED OR REUSED WITHOUT PERMISSION.

DESIGNED FOR: LYDIA BACHMAN

BY: ISABELLE BOUDREAU

	DWN	RV
--	-----	----


DATE

BY

SCALE
1" = 1'-0"

DWG NO.
KB.101

A ELEVATION
1/2" = 1' - 0"

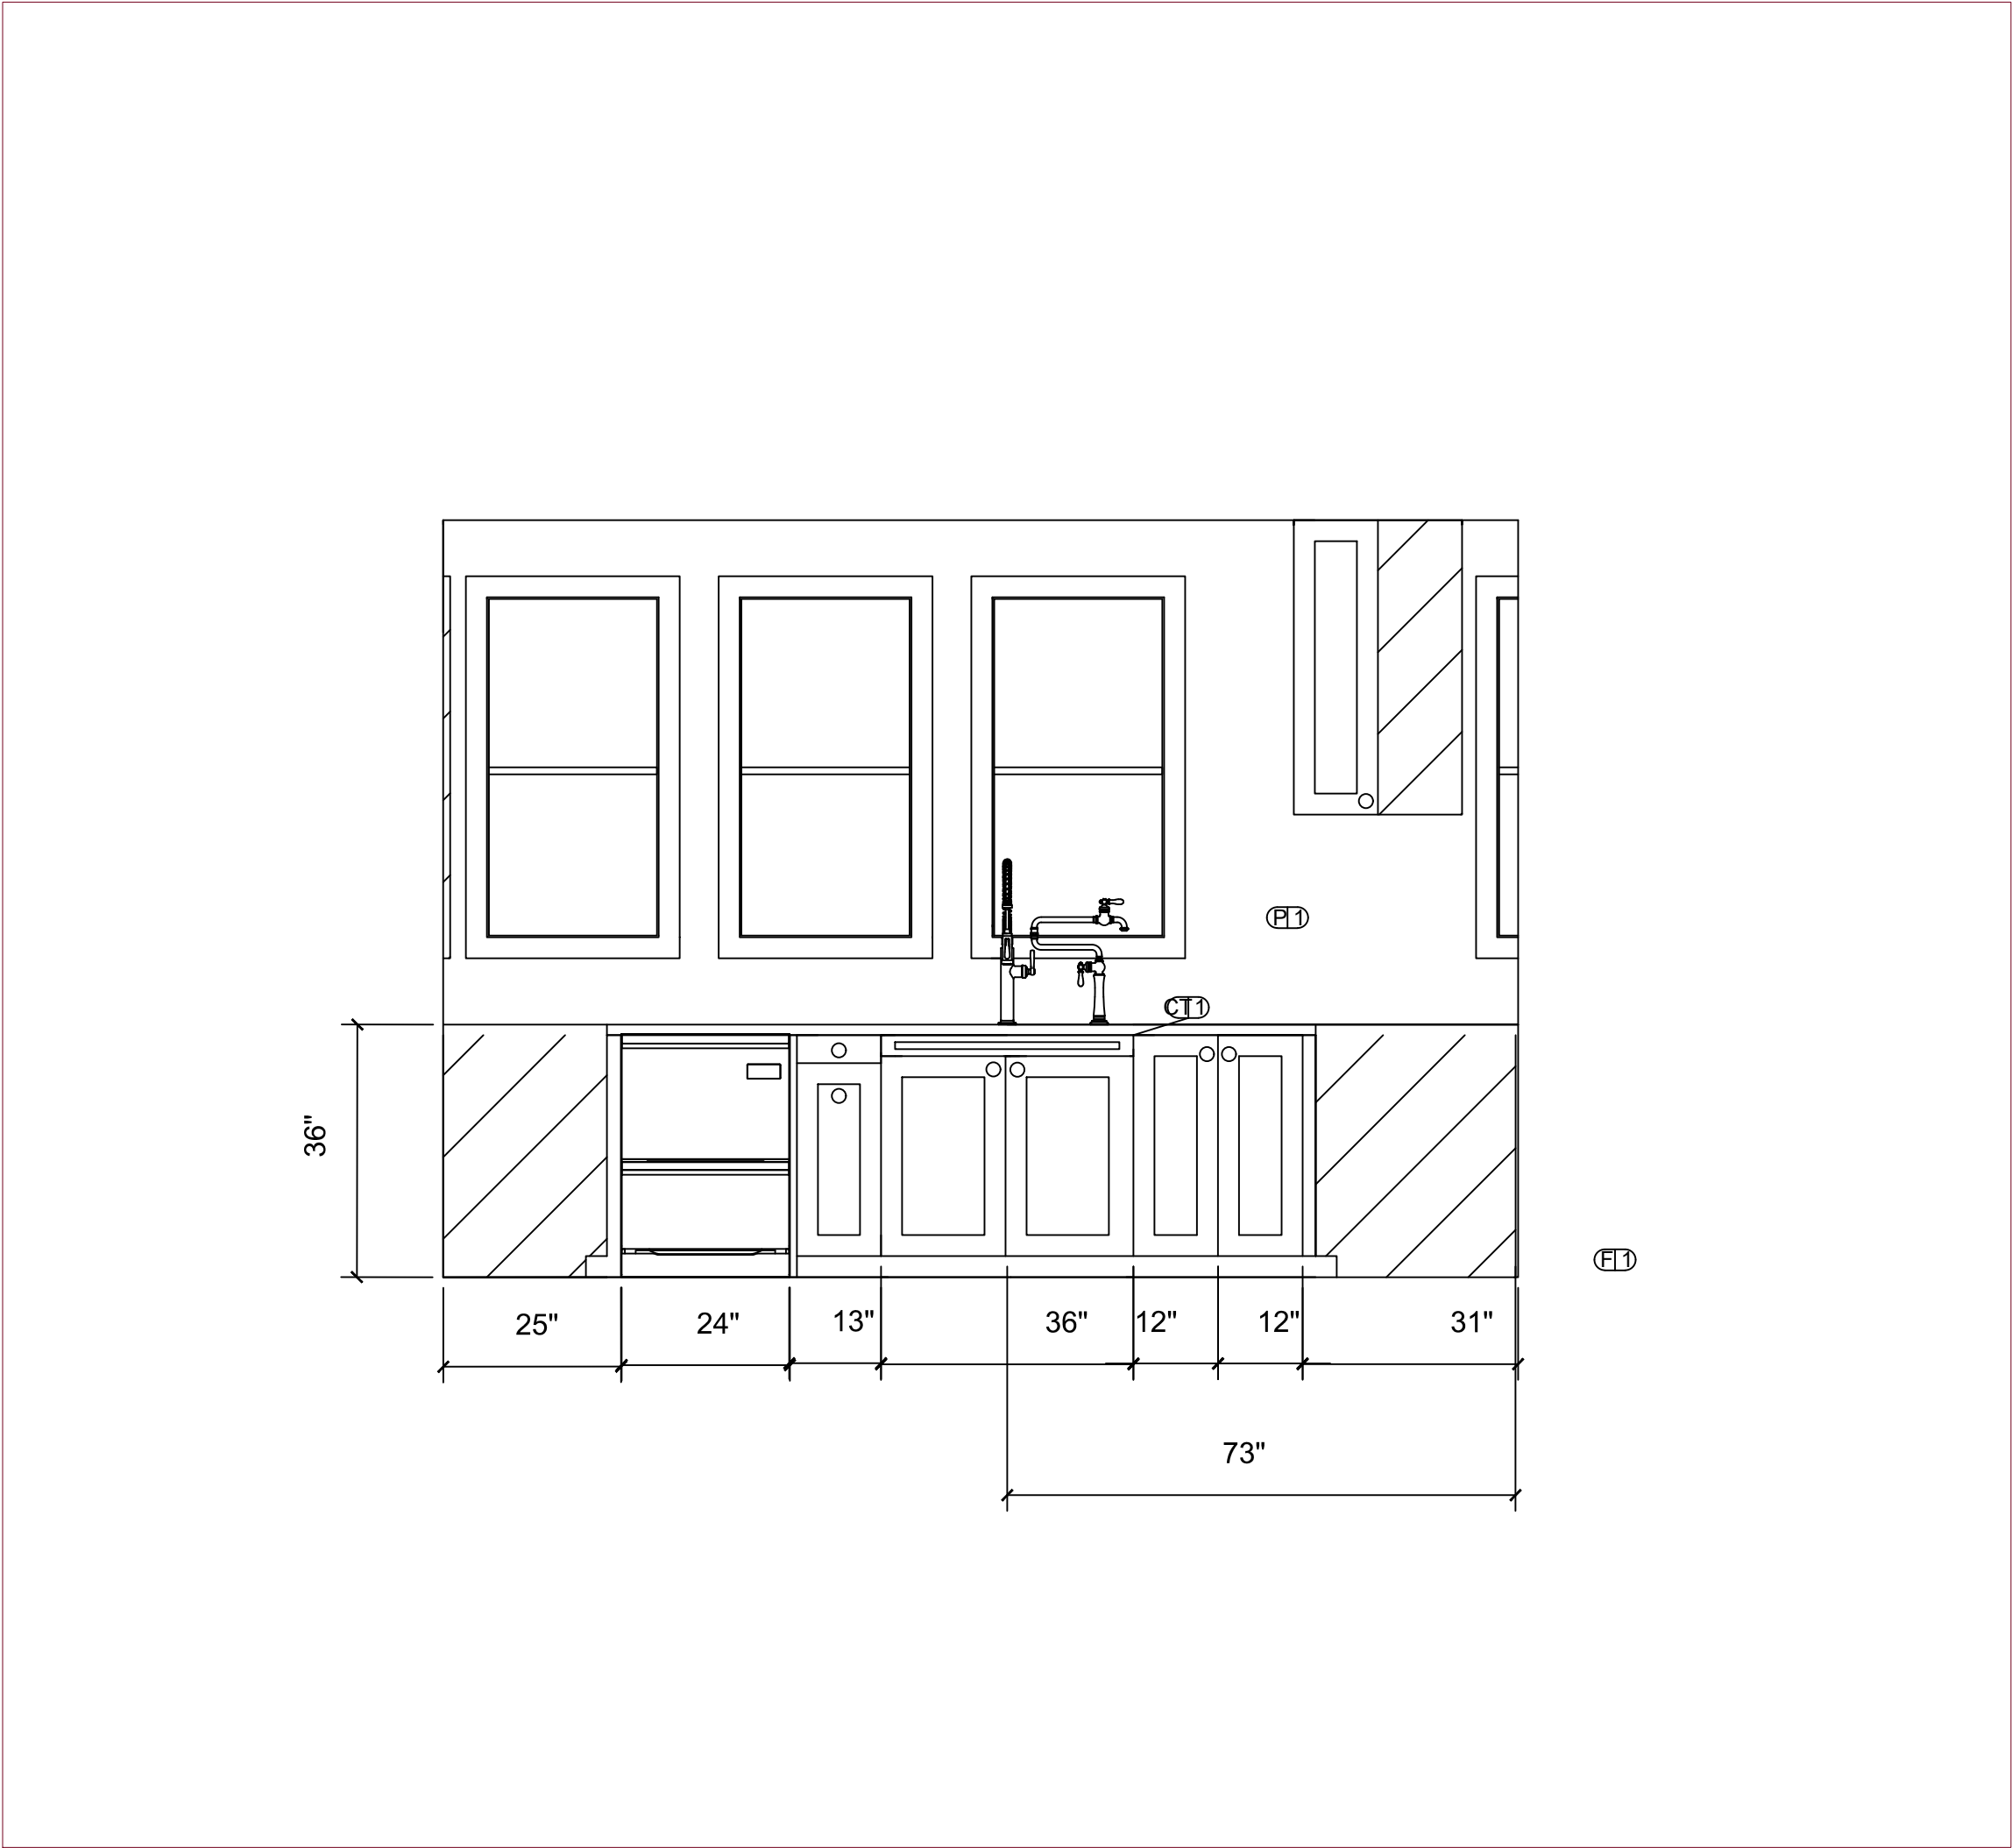

ALL DIMENSIONS AND SIZE DESIGNATIONS GIVEN ARE SUBJECT TO VERIFICATION ON JOB SITE AND ADJUSTMENT TO FIT JOB CONDITIONS.

DESIGN PLANS ARE PROVIDED FOR THE FAIR USE BY THE CLIENT OR HIS AGENT IN COMPLETING THE PROJECT AS LISTED WITHIN THIS CONTRACT. DESIGN PLANS REMAIN THE PROPERTY OF THIS FIRM AND CAN NOT BE USED OR REUSED WITHOUT PERMISSION.

DESIGNED FOR: LYDIA BACHMANN


**BY: ISABELLE BOUDREAU
IAN**

	NM	RV
--	----	----

DATE	BY


SCALE
 $\frac{1}{2}" = 1'-0"$

DWG NO.
KB.600

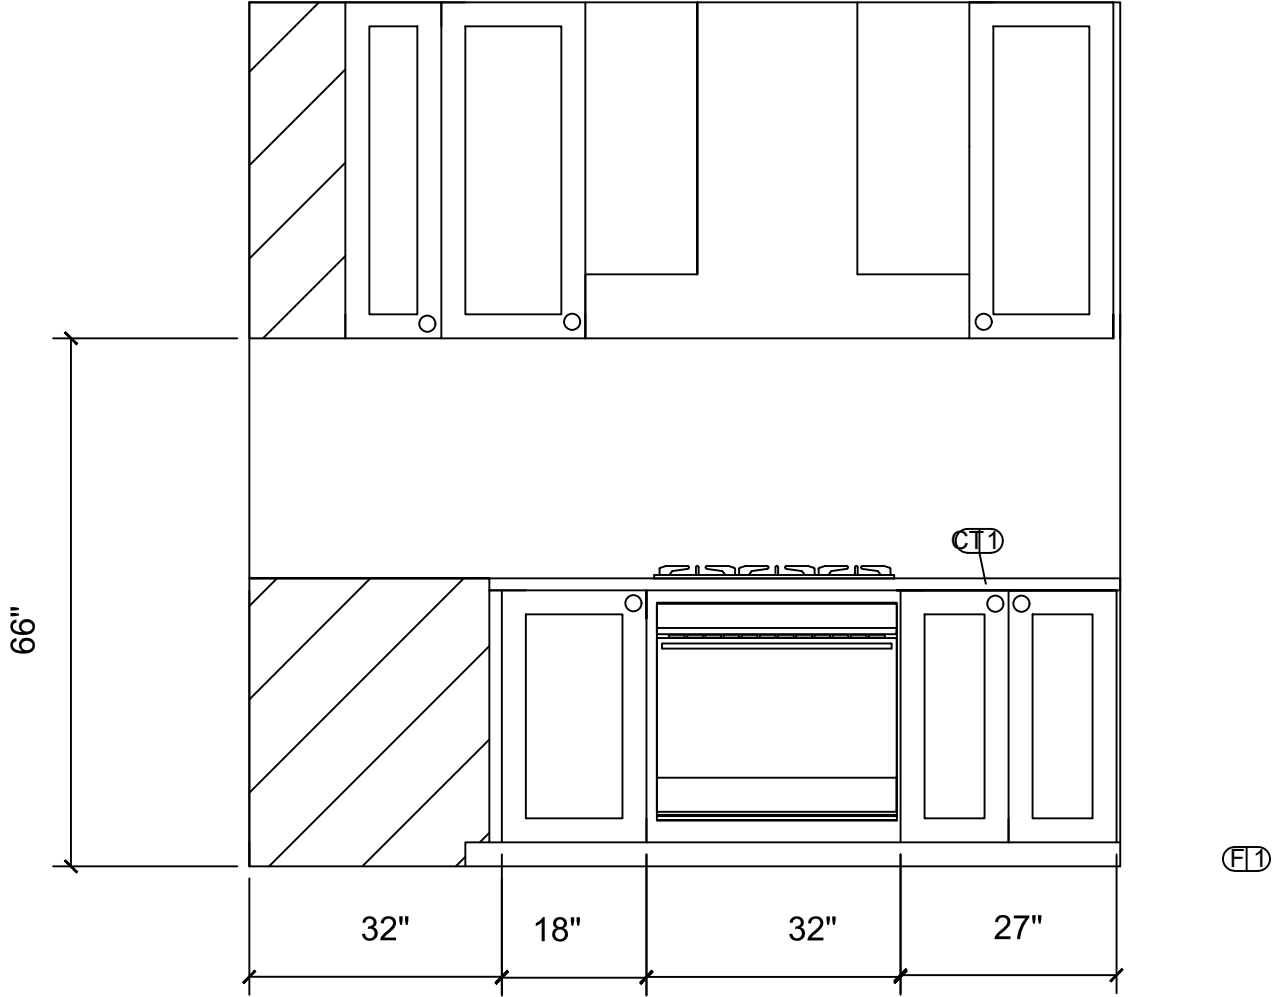

ALL DIMENSIONS AND SIZE DESIGNATIONS GIVEN ARE SUBJECT TO VERIFICATION ON JOB SITE AND ADJUSTMENT TO FIT JOB CONDITIONS.	DESIGNED FOR: <i>LYDIA BACHMAN</i>	BY: <i>ISABELLE BOUDREAU</i>		DATE	BY	SCALE	DWG NO.
			OWN			1/2" = 1'-0"	KB.601
			RV				

A ELEVATION
1/2" = 1' - 0"

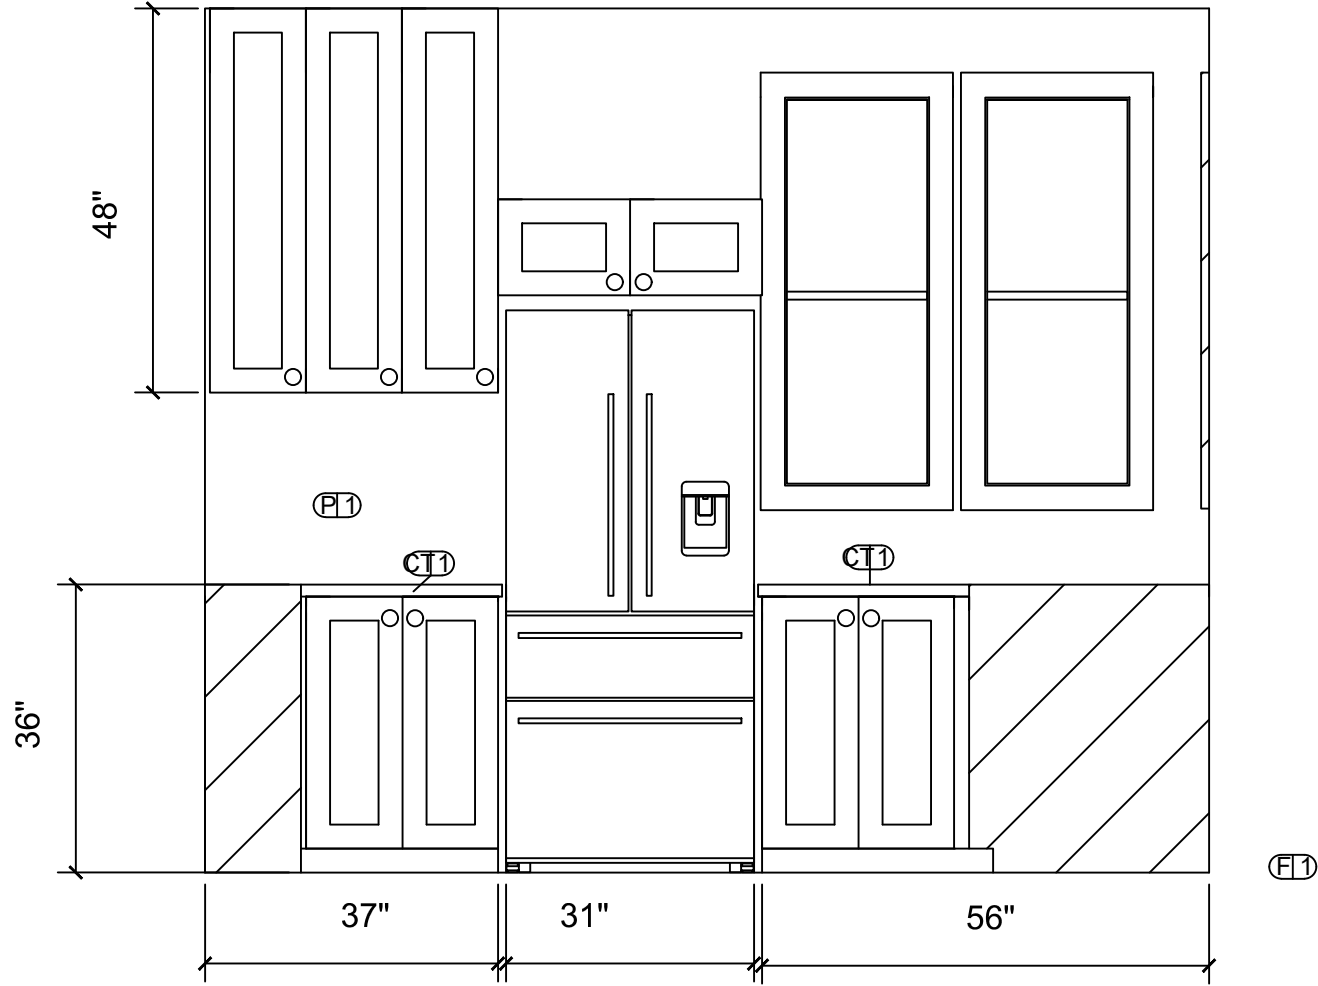

ALL DIMENSIONS AND SIZE DESIGNATIONS GIVEN ARE SUBJECT TO VERIFICATION ON JOB SITE AND ADJUSTMENT TO FIT JOB CONDITIONS.

DESIGN PLANS ARE PROVIDED FOR THE FAIR USE BY THE CLIENT OR HIS AGENT IN COMPLETING THE PROJECT AS LISTED WITHIN THIS CONTRACT. DESIGN PLANS REMAIN THE PROPERTY OF THIS FIRM AND CAN NOT BE USED OR REUSED WITHOUT PERMISSION.

DESIGNED FOR: **LYDIA BACHMAN**

BY: **ISABELLE BOUDREAU**


OWN
RV

DATE


BY

SCALE
1/2" = 1'-0"


DWG NO.
KB.602

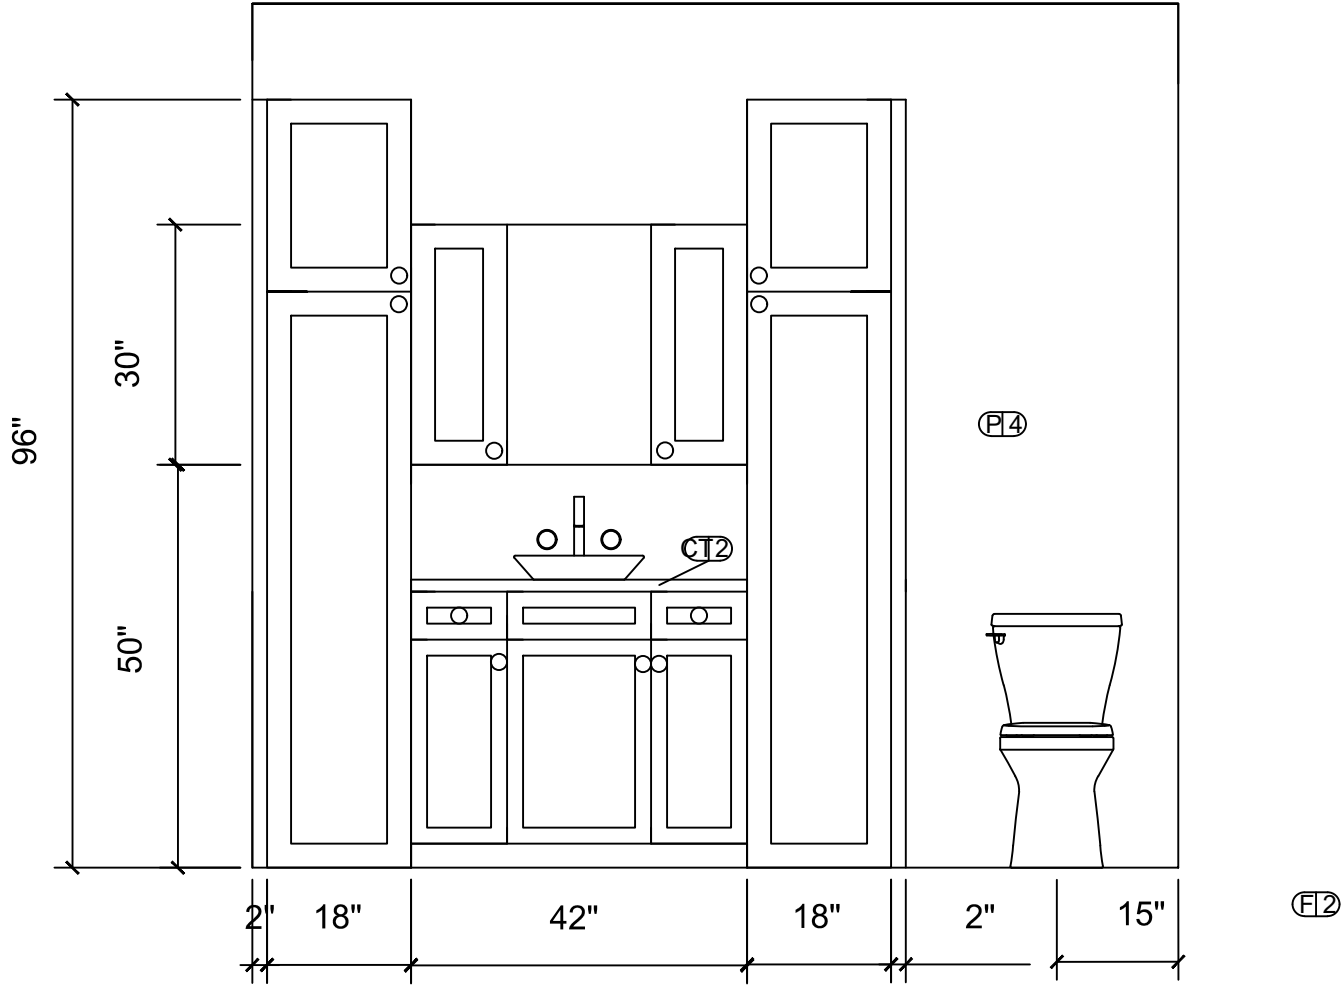

ALL DIMENSIONS AND SIZE DESIGNATIONS GIVEN ARE SUBJECT TO VERIFICATION ON JOB SITE AND ADJUSTMENT TO FIT JOB CONDITIONS.	DESIGN PLANS ARE PROVIDED FOR THE FAIR USE BY THE CLIENT OR HIS AGENT IN COMPLETING THE PROJECT AS LISTED WITHIN THIS CONTRACT. DESIGN PLANS REMAIN THE PROPERTY OF THIS FIRM AND CAN NOT BE USED OR REUSED WITHOUT PERMISSION.	DESIGNED FOR: <i>LYDIA BACHMAN</i>	BY: <i>ISABELLE BOUDREAU</i>	DATE	BY	SCALE	DWG NO.
							1" = 1'-0" KB.603
				OWN			
				RV			

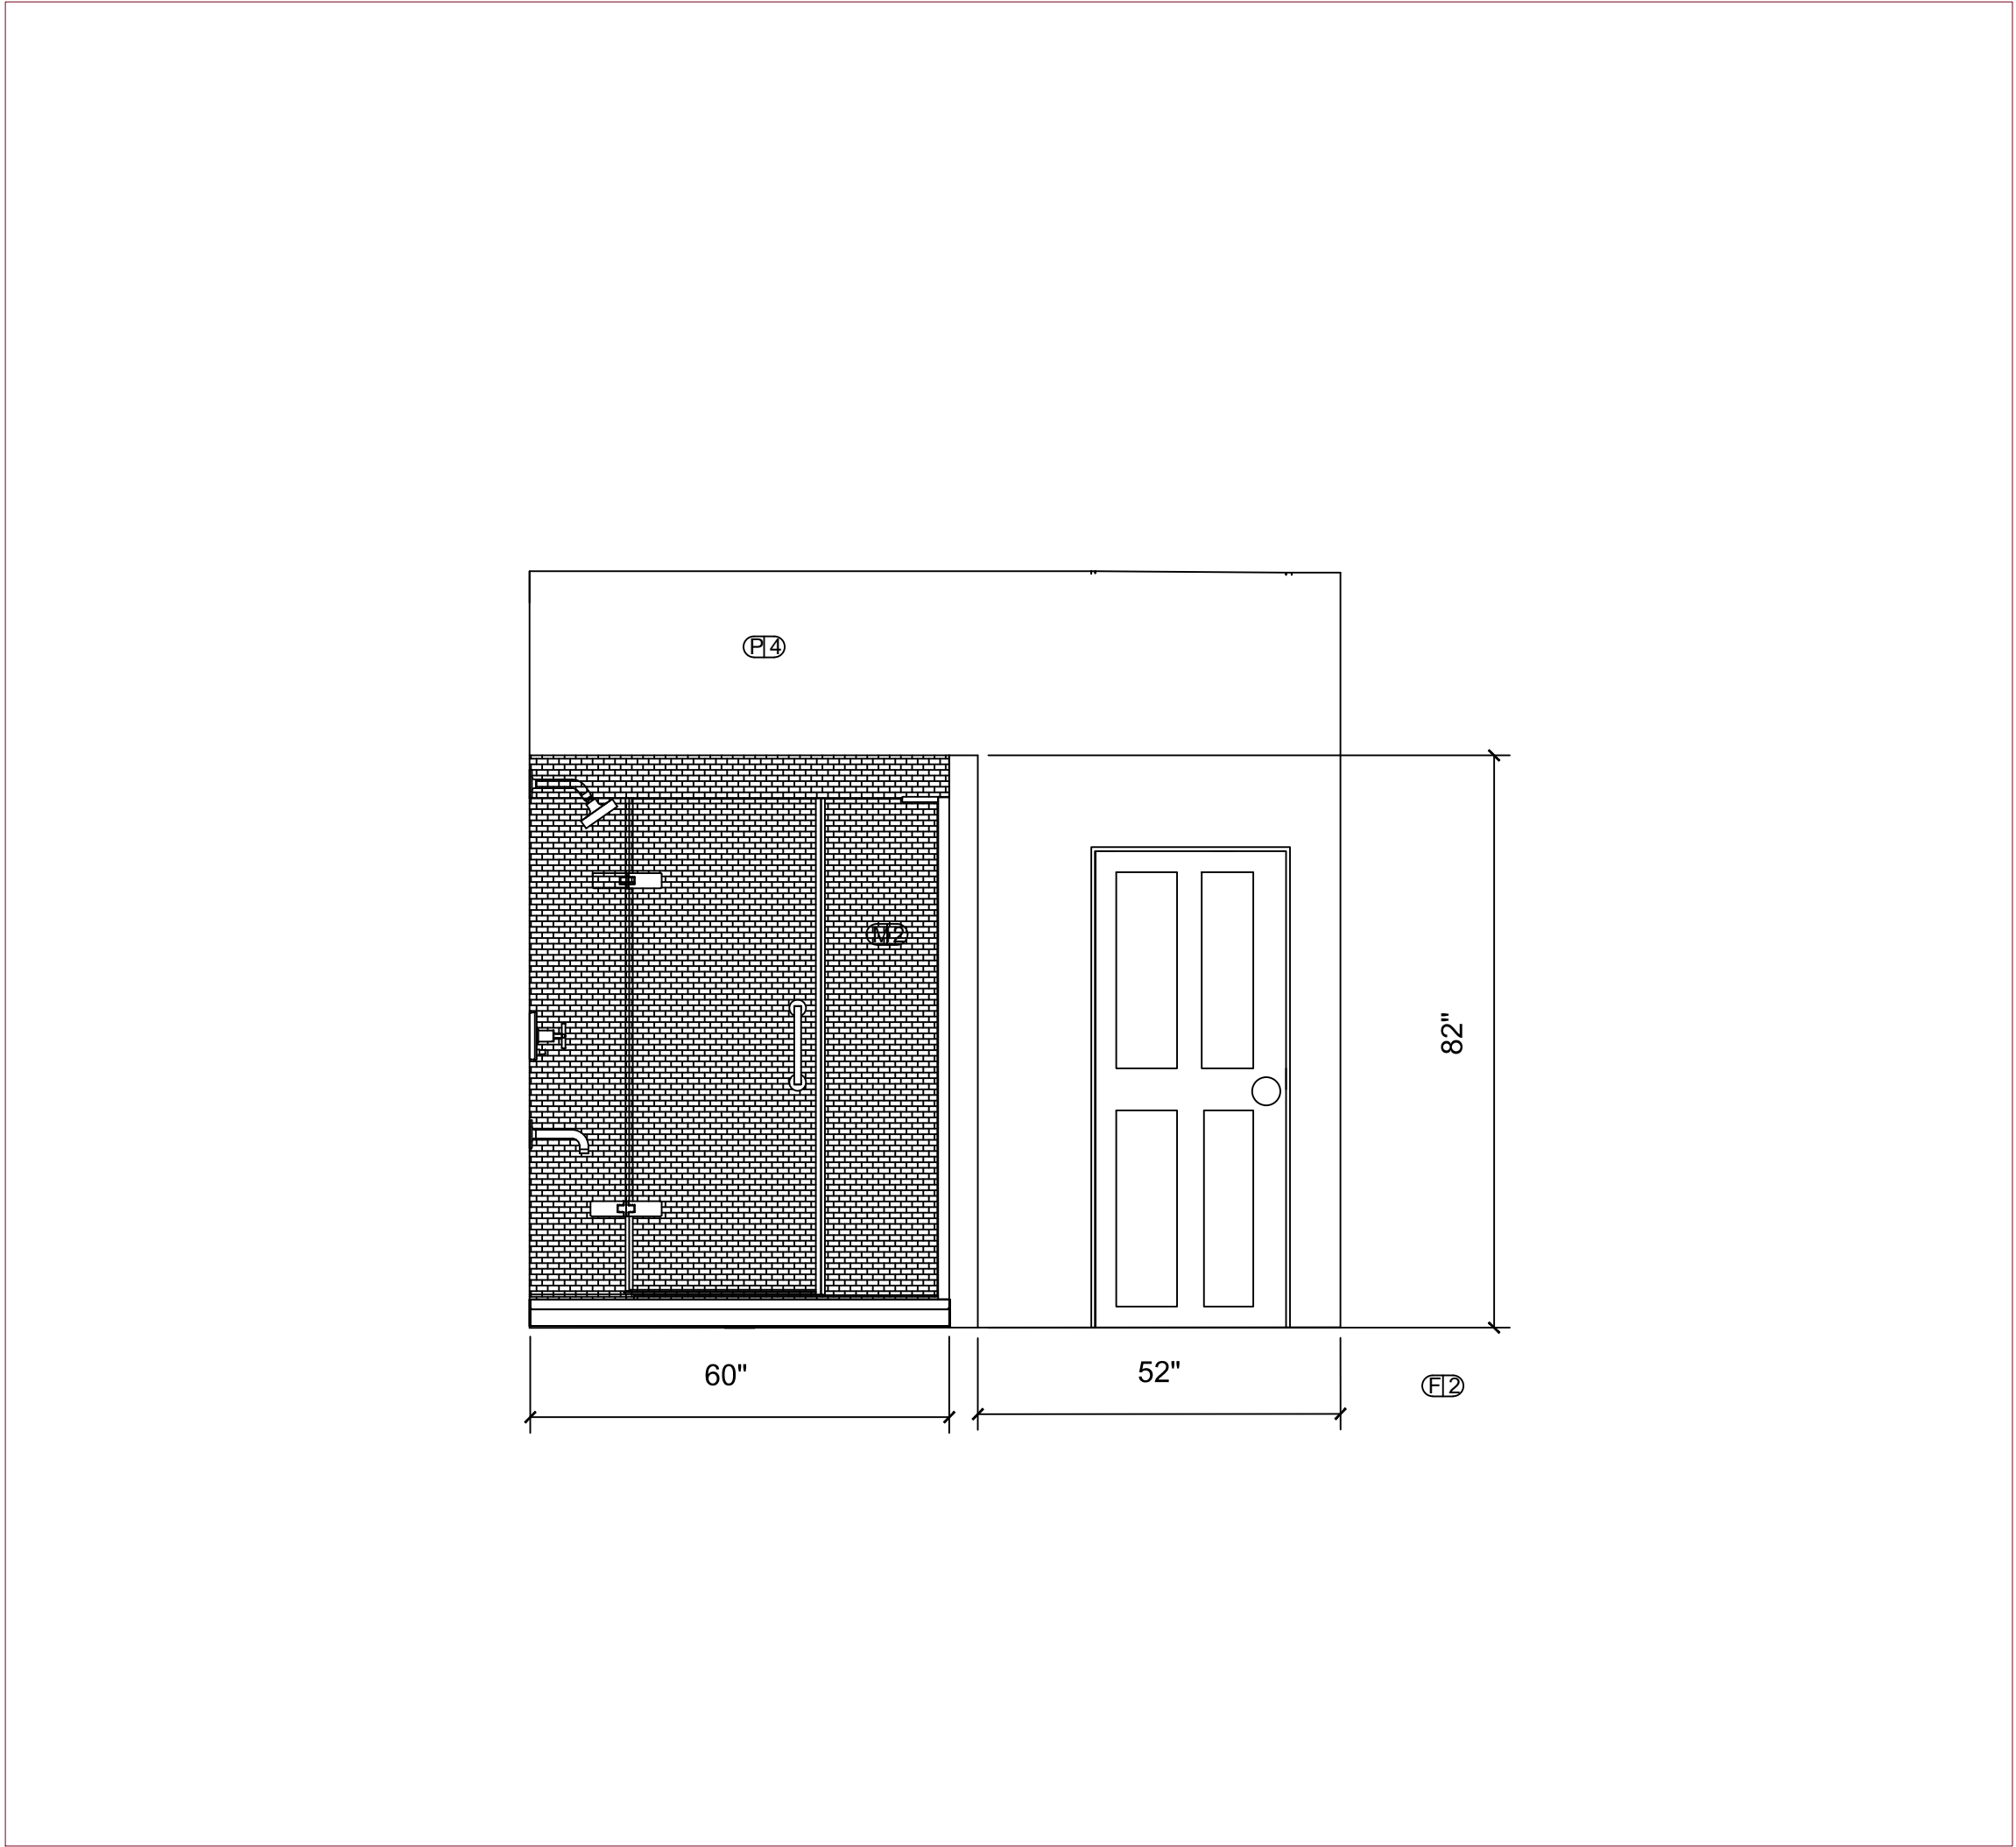

ALL DIMENSIONS AND SIZE DESIGNATIONS GIVEN ARE SUBJECT TO VERIFICATION ON JOB SITE AND ADJUSTMENT TO FIT JOB CONDITIONS.	DESIGNED FOR: <i>LYDIA BACHMAN</i>	BY: <i>ISABELLE BOUDREAU</i>		DATE	BY	SCALE	DWG NO.
			OWN			1/2" = 1'-0"	KB.604
			RV				

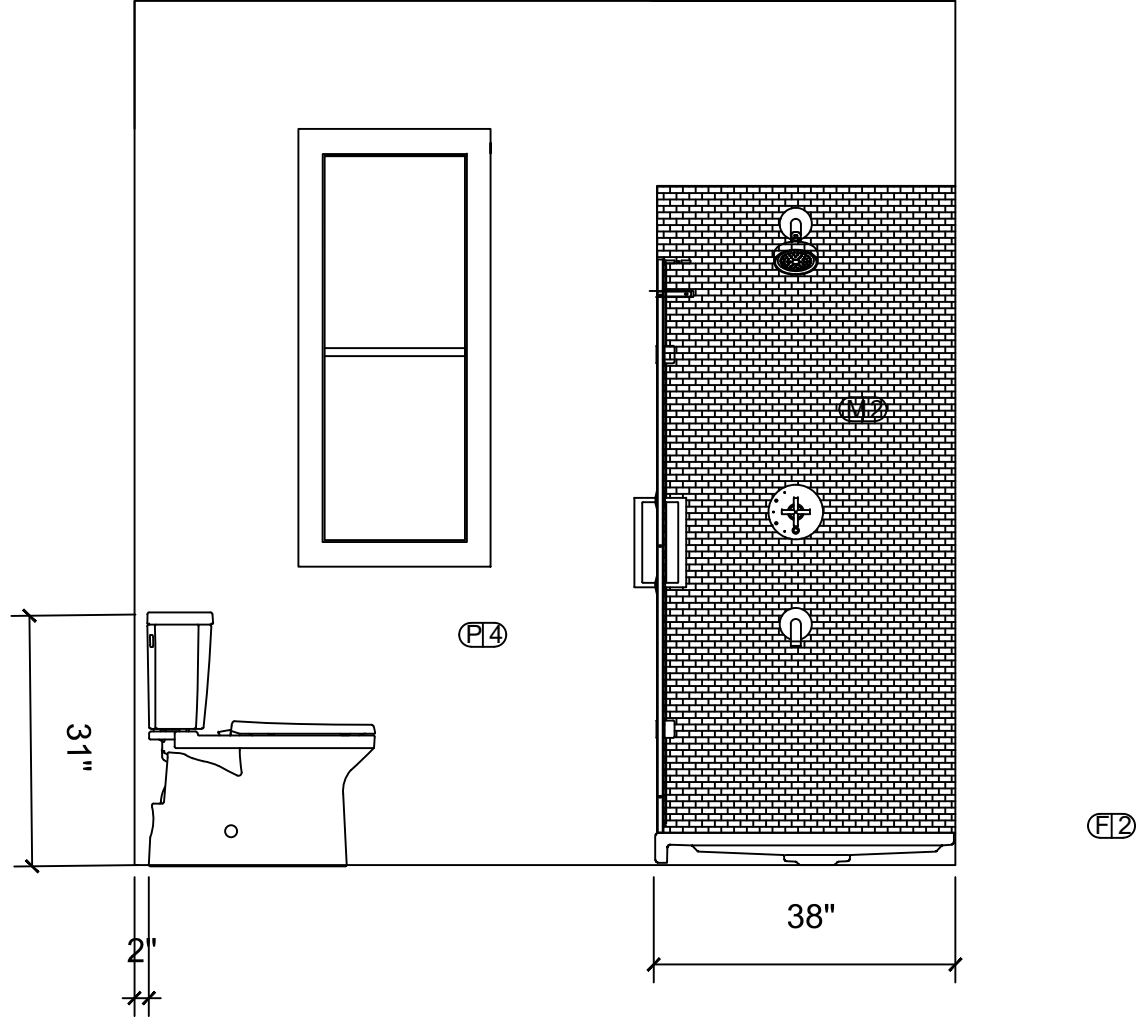

ALL DIMENSIONS AND SIZE DESIGNATIONS GIVEN ARE SUBJECT TO VERIFICATION ON JOB SITE AND ADJUSTMENT TO FIT JOB CONDITIONS.	DESIGNED FOR: <i>LYDIA BACHMAN</i>	BY: <i>ISABELLE BOUDREAU</i>	DATE	BY	SCALE	DWG NO.
					1/2" = 1'-0"	KB.605